




WALL MOUNTED FLOOD LIGHT - "FA"
 1/8" SCALE

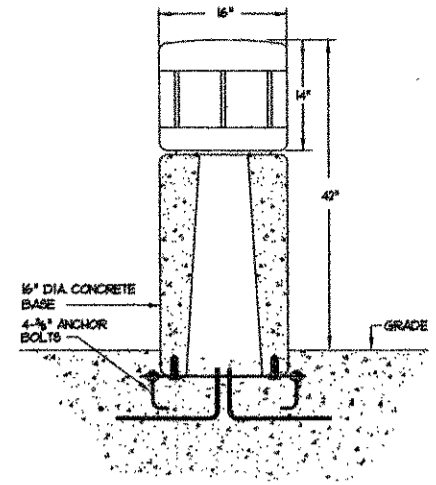


DECORATIVE BOLLARD - "BA"
 SCALE 1/4"

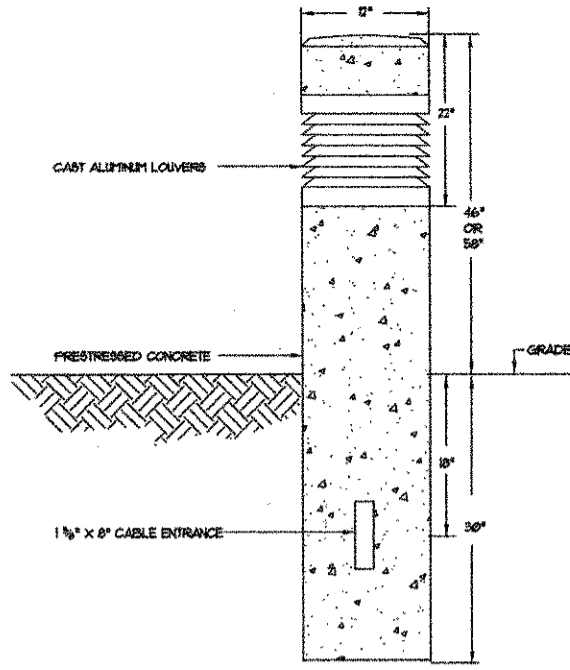


ALTERNATE DECORATIVE BOLLARD - "N01"
 SCALE 1/8"

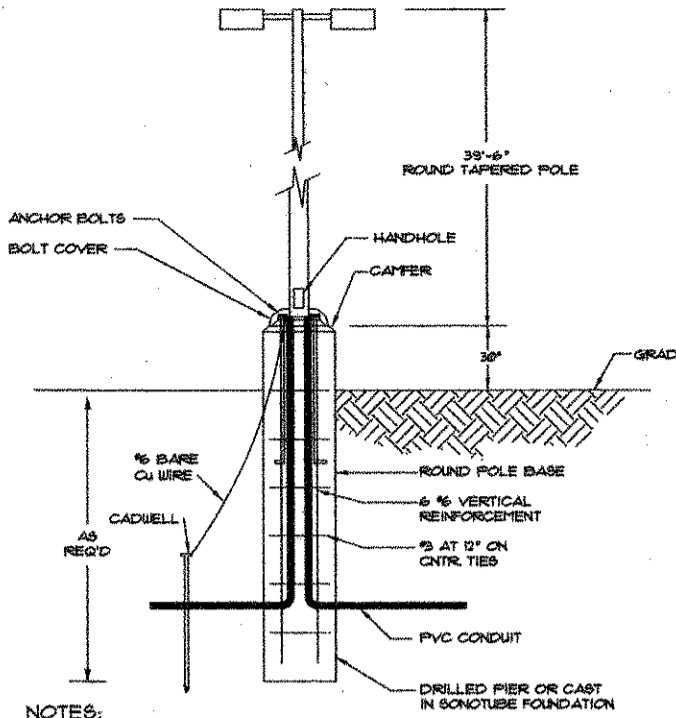

NOTES:
 1. ALL SIZES TO BE VERIFIED BY STRUCTURAL ENGINEER.
 2. ALL LIGHT FIXTURES SHALL HAVE INTERNAL DOWNWARD SHIELDS AS REQUIRED TO DIRECT LIGHT DISTRIBUTION AWAY FROM ADJACENT PROPERTIES.

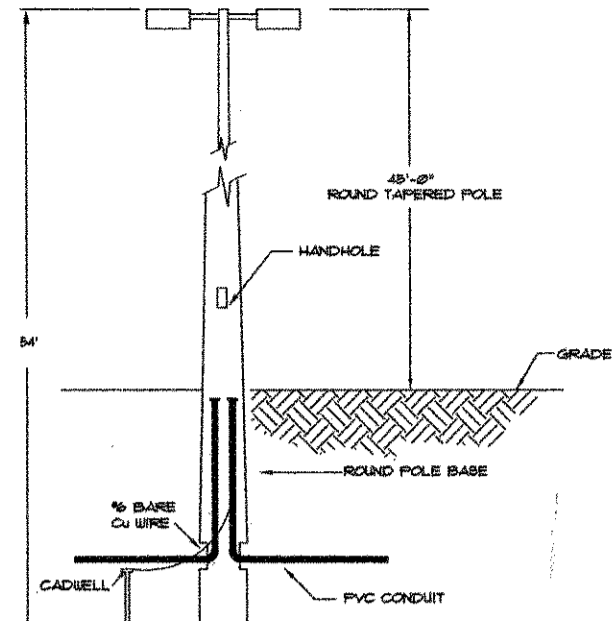

ALTERNATE LIGHT POLE DETAIL - "N02"

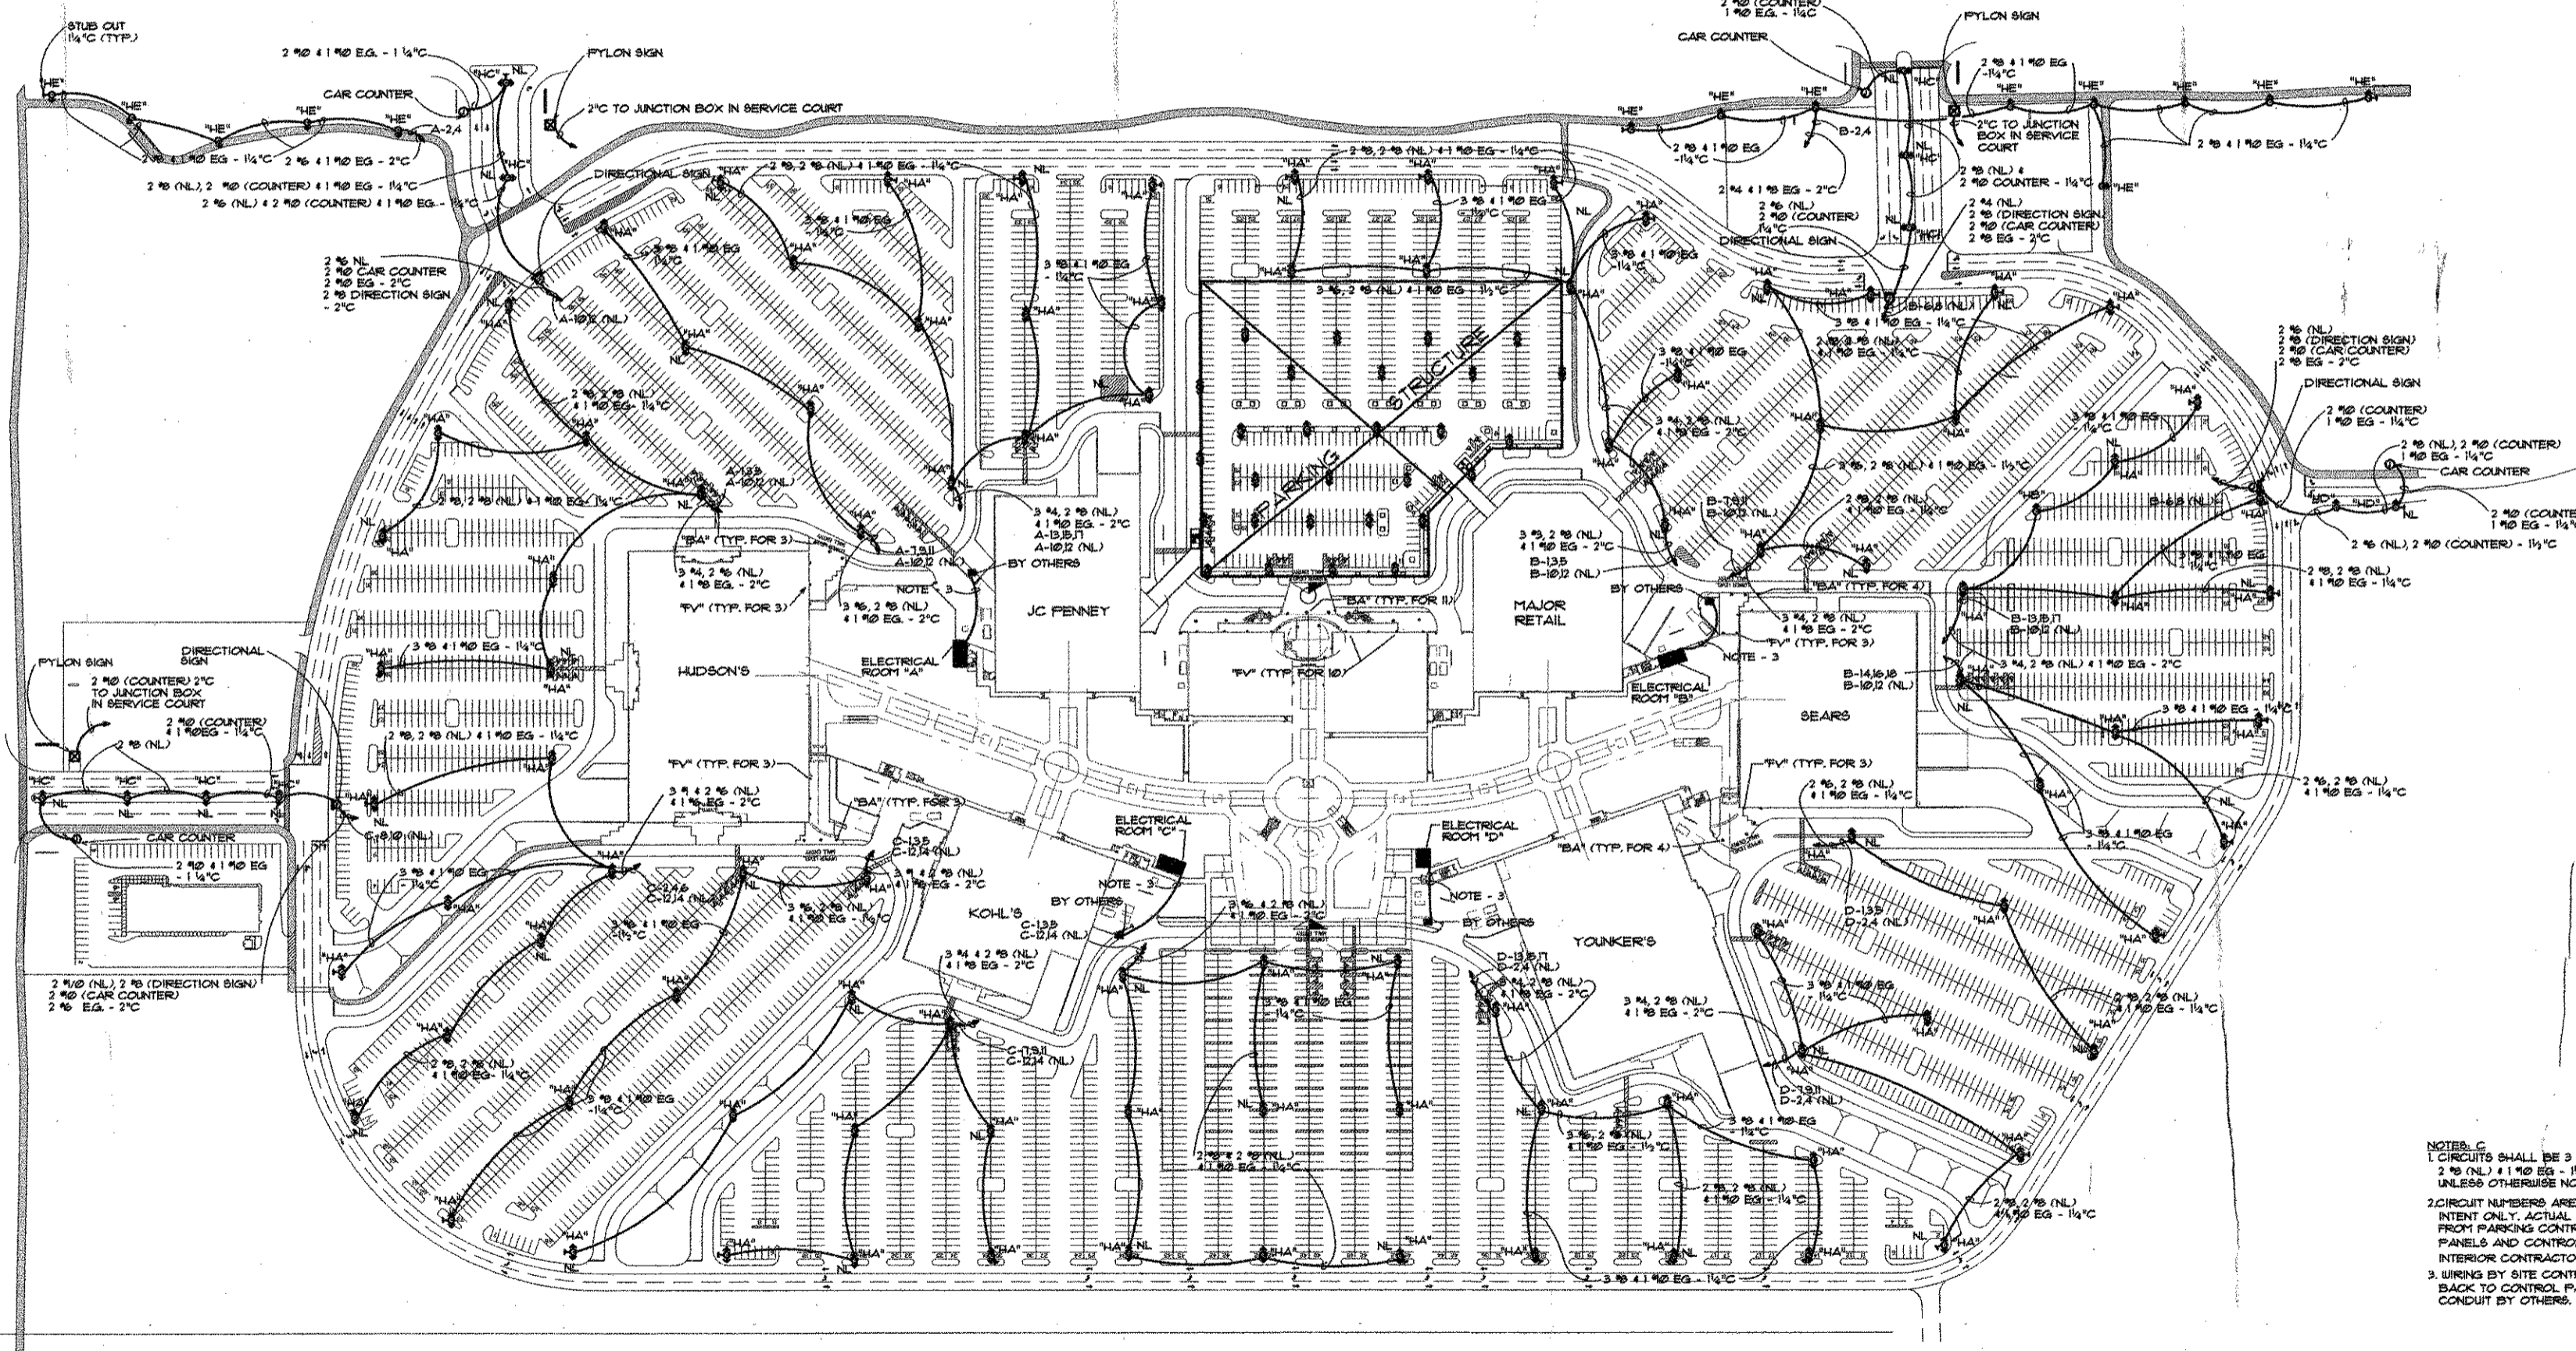

NOTES: C
 1. CIRCUITS SHALL BE 3 #, 2 # (NL) + 1 #0 EG - 1 1/4" UNLESS OTHERWISE NOTED.
 2. CIRCUIT NUMBERS ARE SHOWN FOR INTENT ONLY. ACTUAL CIRCUITING FROM PARKING CONTROL PANELS, PANELS AND CONTROLS BY INTERIOR CONTRACTOR.
 3. WIRING BY SITE CONTRACTOR BACK TO CONTROL PANEL, CONDUIT BY OTHERS.

PARKING LOT LIGHTING PLAN
 SCALE 1"=100'
 NORTH

GRANDVILLE MALL
GRANDVILLE MI.

SHEET TITLE
PARKING LOT SITE LIGHTING PLAN

PROJECT NUMBER
97518C

PROJECT DATE
 DRAWN BY
AOH
 SCALE
1"=100'

CHECKED BY
 APP'D BY

ISSUED FOR
BIDS 5-15-98
CONSTRUCTION 6-12-98

SHEET NUMBER
SL1